

A B C D E F G

1

2

3

4


5

6

7

8

9

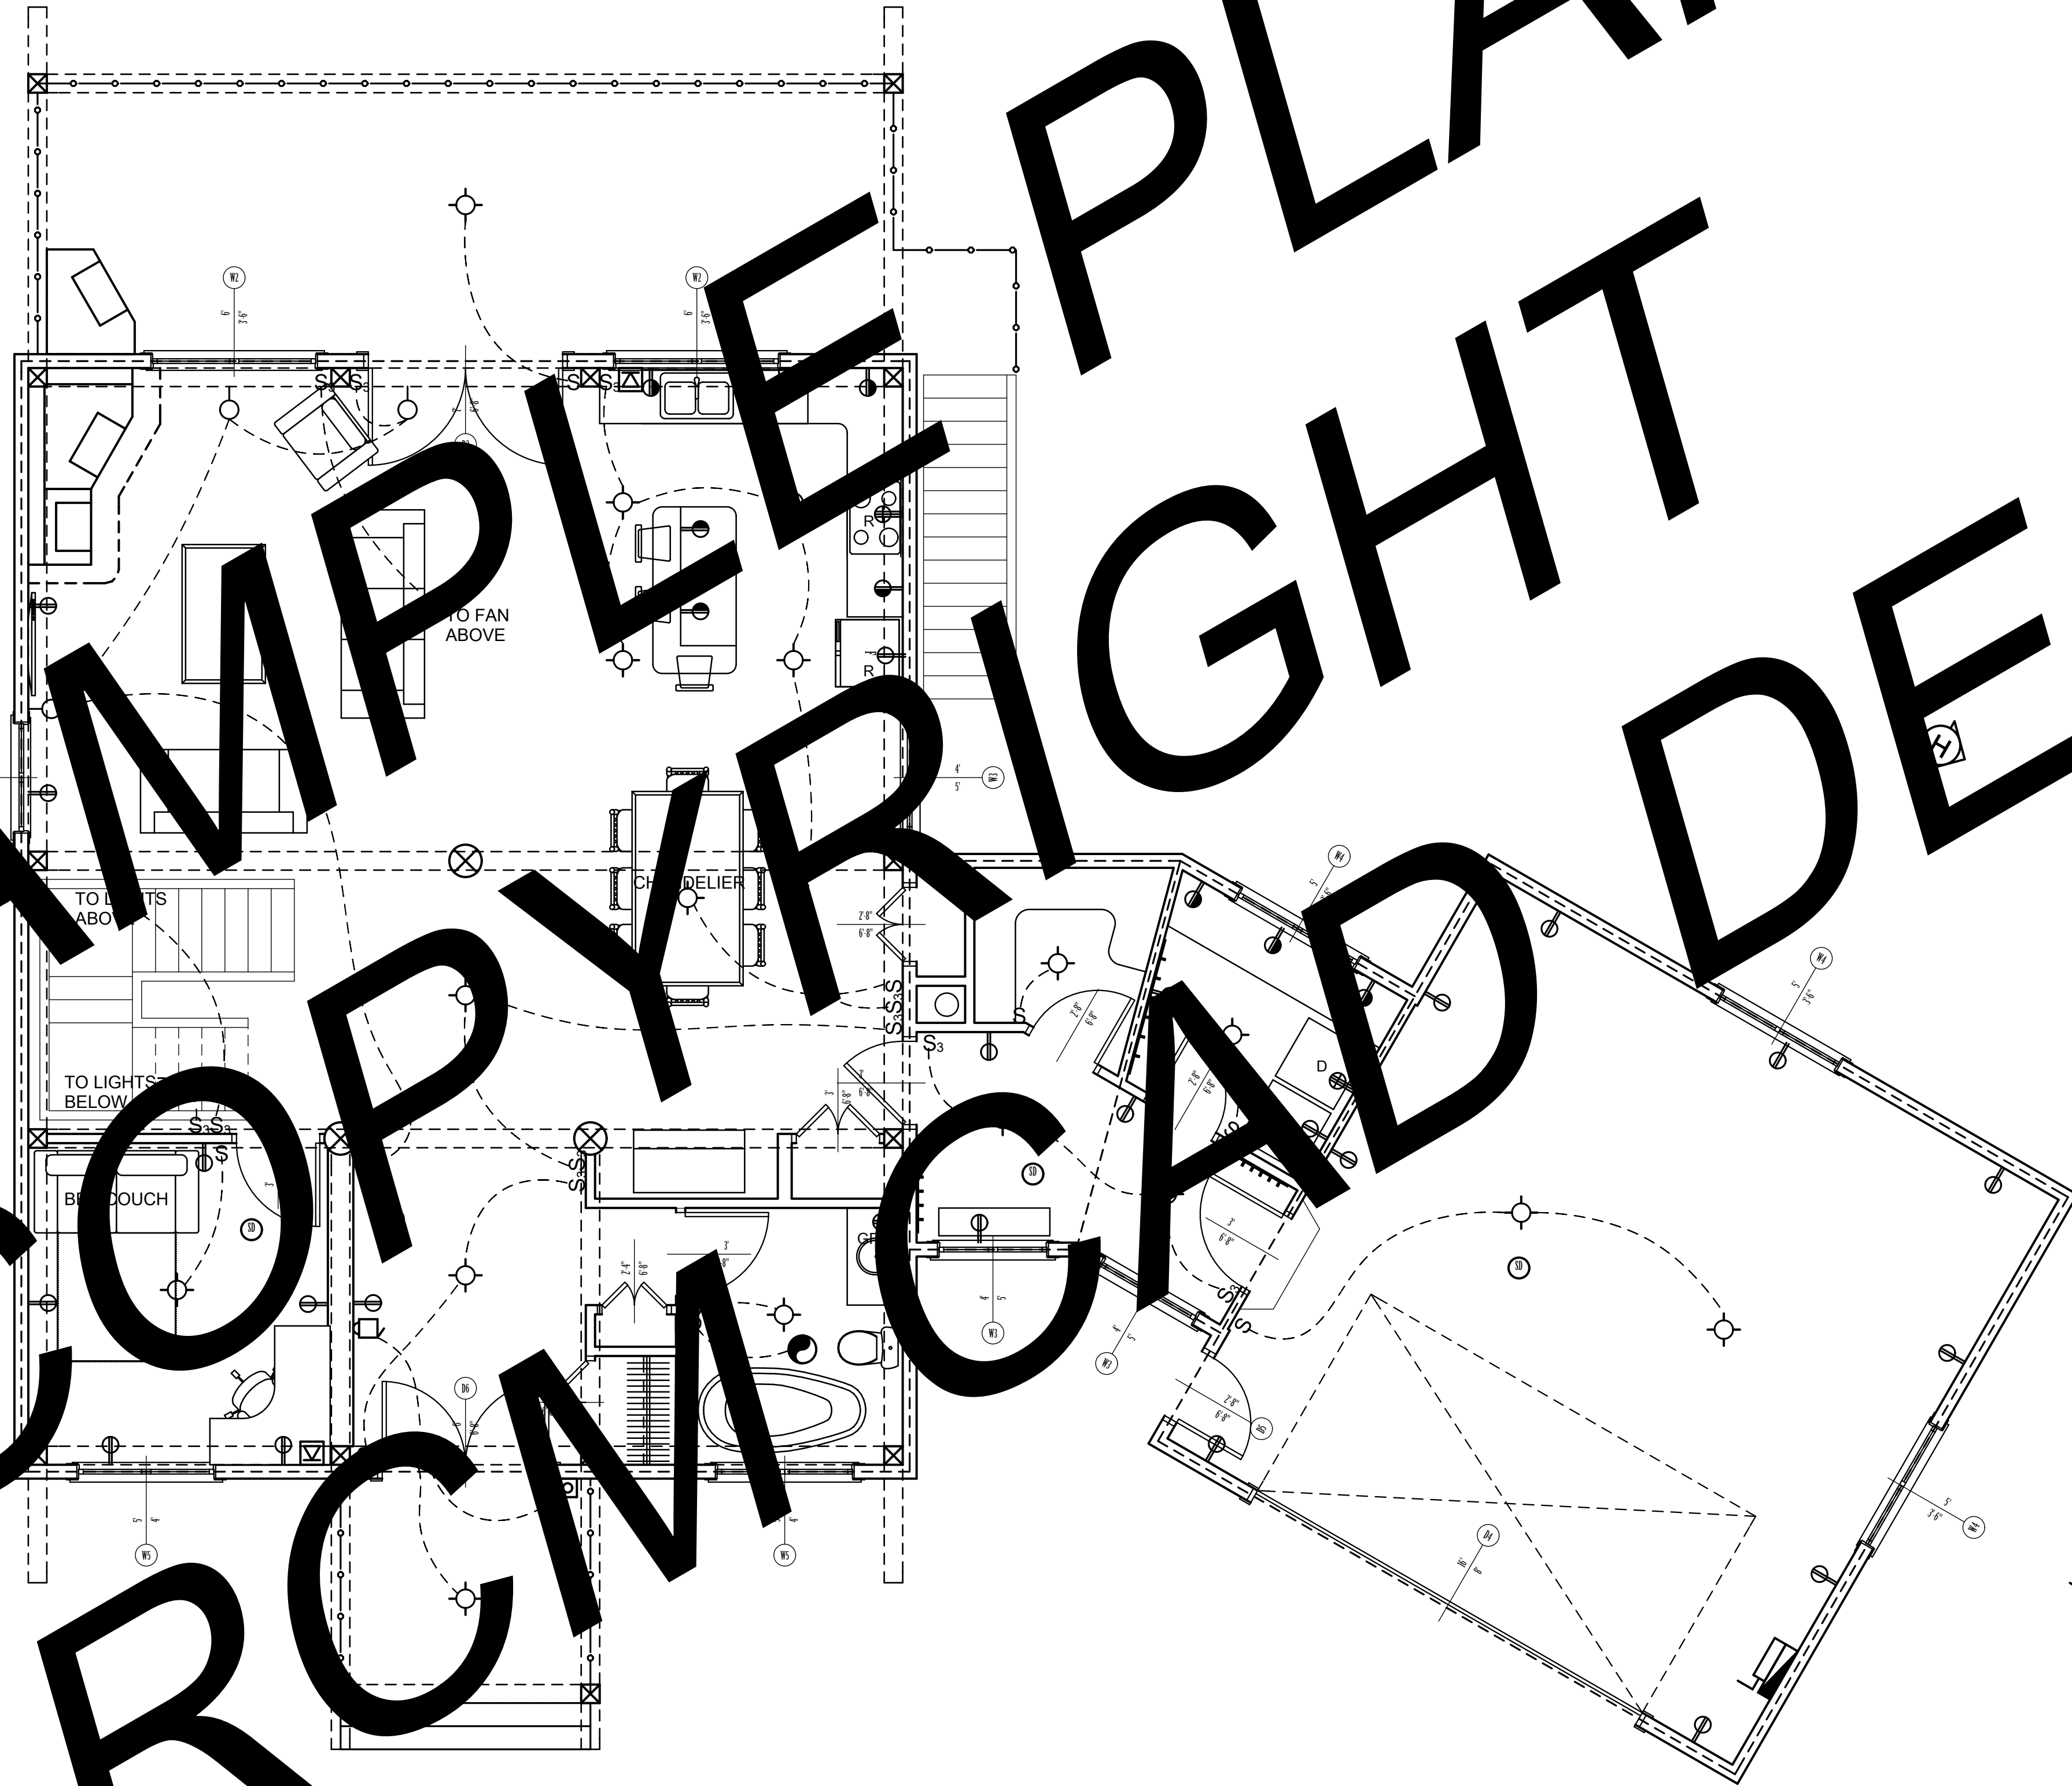

FIRST FLOOR ELECTRICAL PLAN

ELECTRICAL LEGEND						
SYMBOL	DESCRIPTION	VOLT	WATT	WIRES	OUTLET	REMARKS
⊕	DUPLEX RECEPTACLE	120	1200	2#12+	↓ 5-15 R	
⊕ <sub>WP</sub>	OUTSIDE DUPLEX RECEPTACLE	120	1200	2#12+	↓ 5-15 R	
⊕ <sub>R</sub>	REFRIGERATOR RECEPTACLE	120	1200	2#12+	↓ 5-15 R	
⊕ <sub>W</sub>	WASHER RECEPTACLE	120	1200	2#12+	↓ 5-15 R	
⊕ <sub>D</sub>	DRYER RECEPTACLE	240	5200	3#10+	↓ 14-30 R	
⊕ <sub>R</sub>	RANGE RECEPTACLE	240	5200	3#10+	↓ 14-30 R	
⊕	DUPLEX REC. SPLIT CIRCUIT	120	1200	2#12+	↓ 5-15 R	
⊕ <sub>DW</sub>	DISH WASHER RECEPTACLE	120	1200	2#12+	↓ 5-15 R	
⊕ <sub>FR</sub>	FREEZER RECEPTACLE	240	5200	3#10+	↓ 14-30 R	
⊕ <sub>GFCI</sub>	GROUND FAULT CIRCUIT INTERRUPTER	120	1200	2#12+	5-15 R	
⊕	FAN RECEPTACLE	120	1200	2#12+	↓ 5-15 R	
☐	PHONE					
⊕	CABLE OUTLET					
⊕	BROADBAND CABLE					
*	SATELLITE CABLE					
⊕	SMOKE ALARM RECEPTACLE	120	1200	2#12+	↓ 5-15 R	
⊕	BELL/BUZZER RECEPTACLE	120	1200	2#12+	↓ 5-15 R	
⊕	PUSH BUTTON RECEPTACLE	120	1200	2#12+	↓ 5-15 R	
⊕	FILING CABINET	1200		2#12+	↓ 5-15 R	
⊕	PRESSED AIR OUTLET	120	1200	2#12+	↓ 5-15 R	
⊕	VACUUM OUTLET	120	1200	2#12+	↓ 5-15 R	
⊕	MOTION SENSOR LIGHT	120	1200	2#12+	↓ 5-15 R	
⊕	1-4" FLUORESCENT	120	1200	2#12+	↓ 5-15 R	
⊕	2-8" FLUORESCENT	120	1200	2#12+	↓ 5-15 R	
⊕	FAN LIGHT COMBO					
S	SINGLE POLE SWITCH	120	1200	2#12+	↓ 5-15 R	
S <sub>3</sub>	THREE WAY SWITCH	120	1200	2#12+	↓ 5-15 R	
S <sub>4</sub>	FOUR WAY SWITCH	120	1200	2#12+	↓ 5-15 R	
⊕	POWER PANEL					
⊕	CIRCUIT BREAKER PANEL					50 CIRCUIT BREAKERS
⊕	METER BASE					
⊕	BASEBOARD HEATER	120	1200	2#12+	↓ 5-15 R	
⊕	THERMOSTAT					

- GENERAL ELECTRICAL NOTES:**
- SERVICE SIZE TO BE 200 AMPS WITH A 50 CIRCUIT BREAKER PANEL. SERVICE BREAKER RATING TO BE 200 AMPS. HOT CONDUCTORS TO BE 2-#1R90 (XLPE) COPPER (BLACK, RED OR BLUE). NEUTRAL CONDUCTOR TO BE 1-#4R90 (XLPE) COPPER (WHITE). SERVICE CONDUIT TO INSIDE TO BE 1 1/4" IN DIAMETER. SERVICE GROUNDING CONDUCTOR TO BE MINIMUM #4 BARE COPPER.
  - ALL WORK TO CONFORM TO PROVINCIAL ELECTRICAL CODE & LOCAL CODE & BYLAWS.
  - ALL ABOVE COUNTER RECEPTACLE TO BE 12" ABOVE TOP OF COUNTER. WASHER & DRYER OUTLETS TO BE BEHIND MACHINES 2" MAX. ABOVE FLOOR. ALL OTHER WALL PLUGS & PHONE OUTLET TO BE 1" ABOVE FLOOR. ALL SWITCHES & THERMOSTATS TO BE 4' ABOVE FLOOR.

NOTE: ALL DIMENSIONS TO BE VERIFIED ON SITE BY GENERAL CONTRACTOR. THIS SET OF PLANS TO BE ENGINEERED & STAMPED BY A PROFESSIONAL ENGINEER. LOCAL BUILDING CODES AND PRACTICES TO BE OBSERVED.

R.C.M. Cad Design  
 Drafting Ltd.  
 298, 343, 401, 402, 403, 999, 1000.

LOG BUILDER: ELK RIDGE  
 CLIENT: ELK RIDGE  
 TITLE: FIRST FLOOR ELECTRICAL PLAN

SCALE: 1/4" = 1'-0"  
 DATE: MAY 28, 2008  
 DRAWN BY: C.C.  
 CHECKED BY: C.C.

REVISION: REV. 1, REV. 2, REV. 3

A-14 20