


A  
 B  
 C  
 D  
 E  
 F  
 G  
 H  
 I  
 J  
 K  
 L  
 M  
 N  
 O  
 P  
 Q  
 R  
 S  
 T  
 U  
 V  
 W  
 X  
 Y  
 Z  
 AA  
 BB  
 CC  
 DD  
 EE  
 FF  
 GG  
 HH  
 II  
 JJ

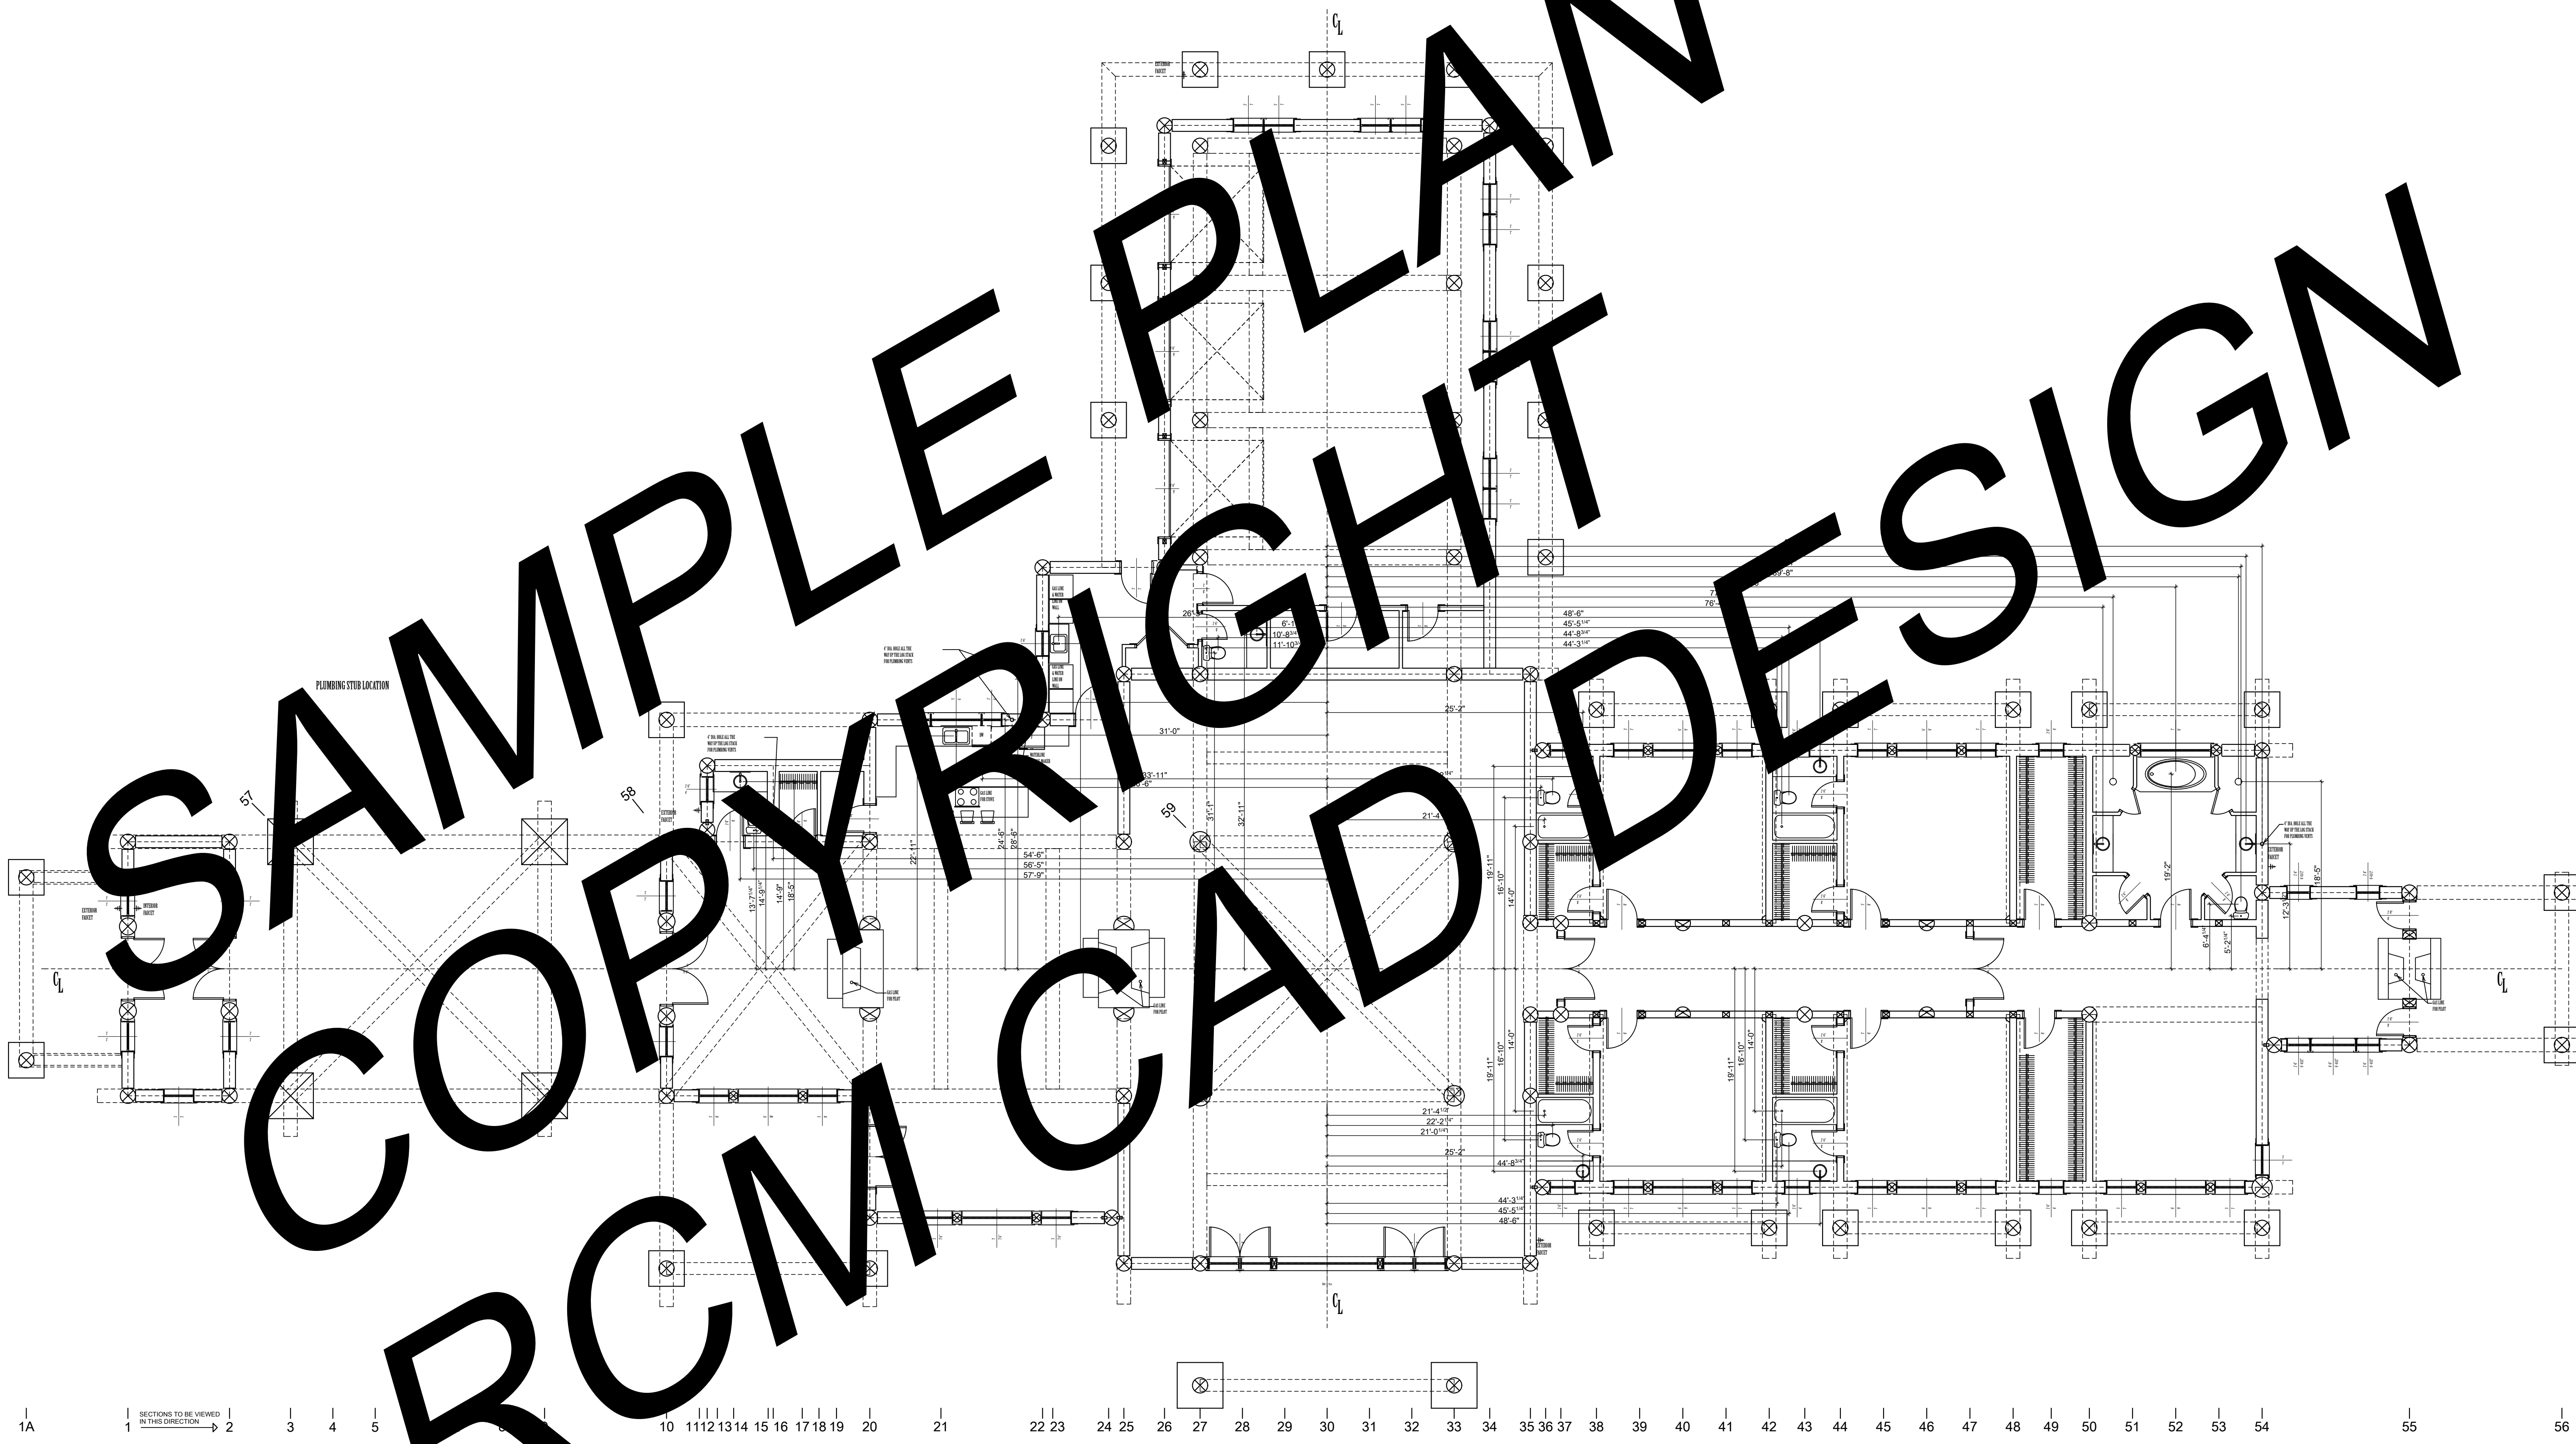

SAMPLE RIGHT PLAN  
 RCM CAD DESIGN

15	LOG BUILDER:	WYOMING	SCALE:	1/8" = 1'-0"	REVISION:	DATE:	DESCRIPTION:
	CLIENT:	PLUMBING PLAN	DATE:	JAN. 16, 2007	REV. 1		
	TITLE:		DRAWN BY:	C.C.	REV. 2		
			CHECKED BY:	C.C.	REV. 3		

24

NOTE:  
 • ALL DIMENSIONS TO BE VERIFIED ON SITE BY GENERAL CONTRACTOR  
 • IT IS THE SOLE RESPONSIBILITY OF THE GENERAL CONTRACTOR TO COMPLETE SET OF PLANS TO BE ENGINEERED & SEALED BY LICENSED ENGINEER

**R.C.M. Cad Design**  
**Drafting Ltd.**  
 RCM CAD DESIGN  
 PO BOX 800  
 SUMAS, WYOMING 82641  
 PHONE: (604) 850-8723 FAX: (604) 850-8724  
 www.rcmhomebasedesign.ca

• ALL DIMENSIONS TO BE VERIFIED ON SITE BY GENERAL CONTRACTOR  
 • IT IS THE SOLE RESPONSIBILITY OF THE GENERAL CONTRACTOR TO CHECK & VERIFY ALL DIMENSIONS & SPECIFICATIONS ON THIS SET OF PLANS BEFORE STARTING CONSTRUCTION  
 • BUILDER IS RESPONSIBLE FOR COMPLYING WITH ALL LOCAL BUILDING CODES AND PRACTICES